





A

B

C

D

REV	ECO	DWG	DATE
A	66904	DDC	12-19-90

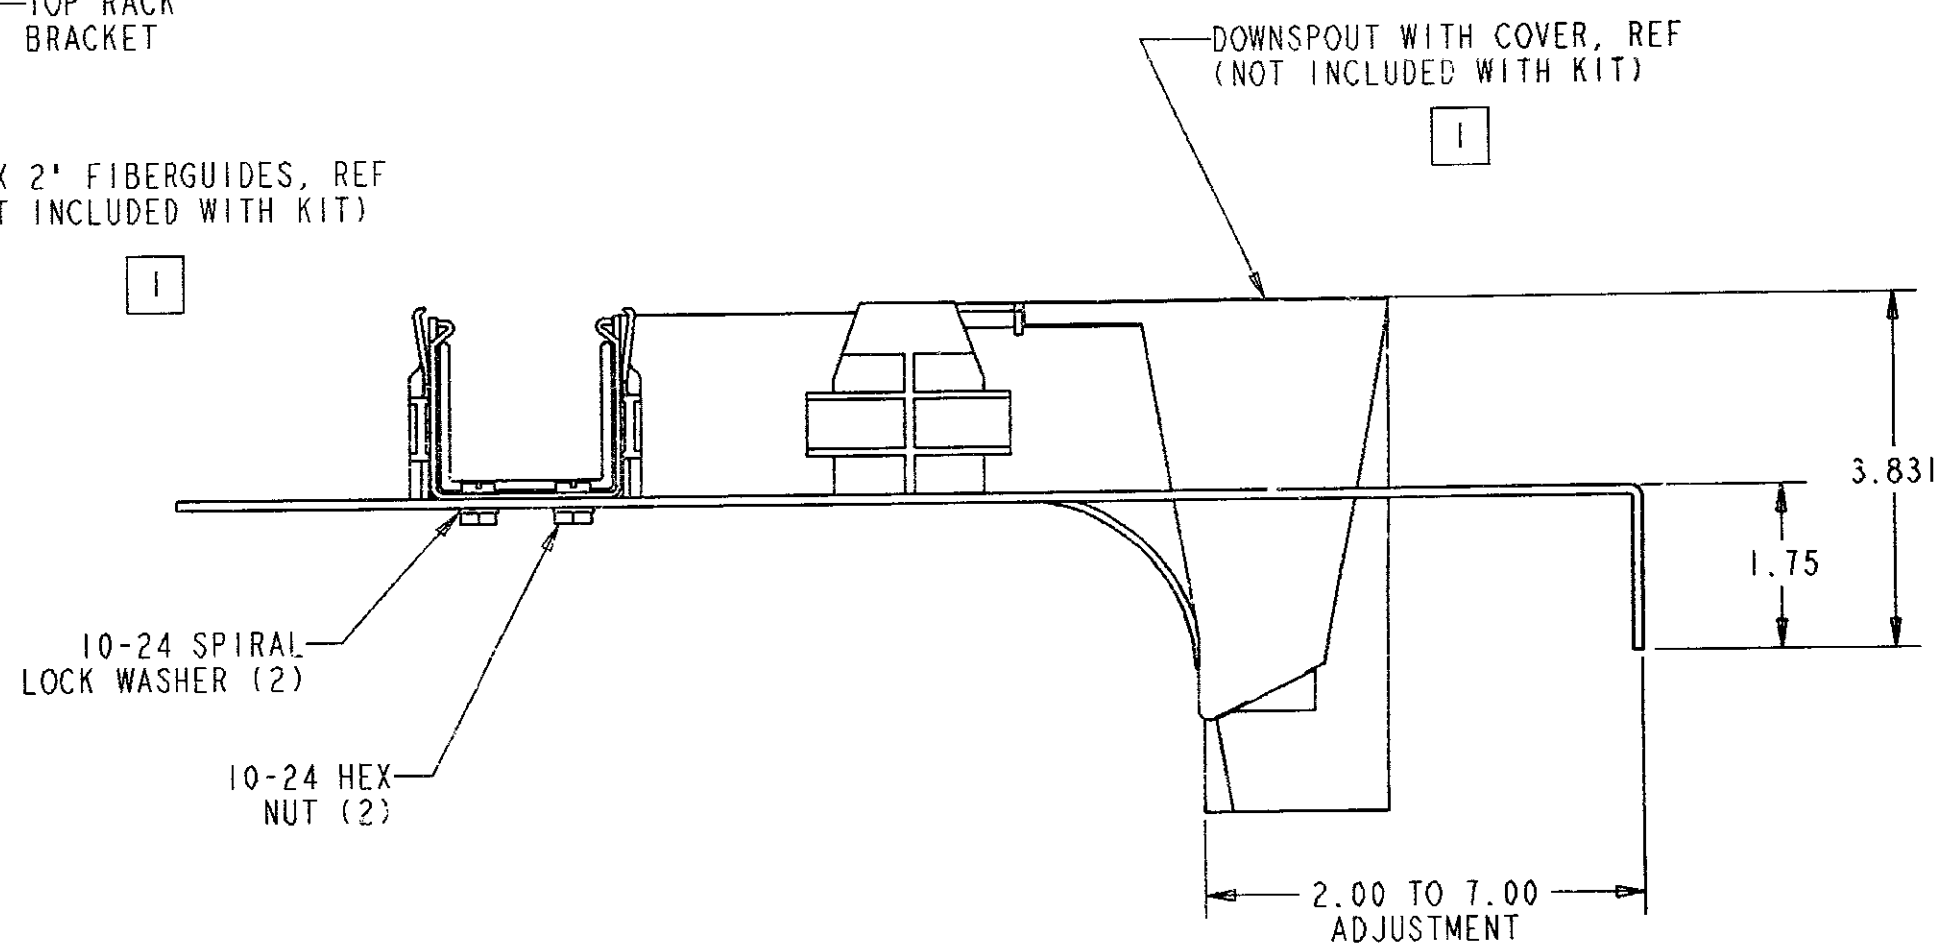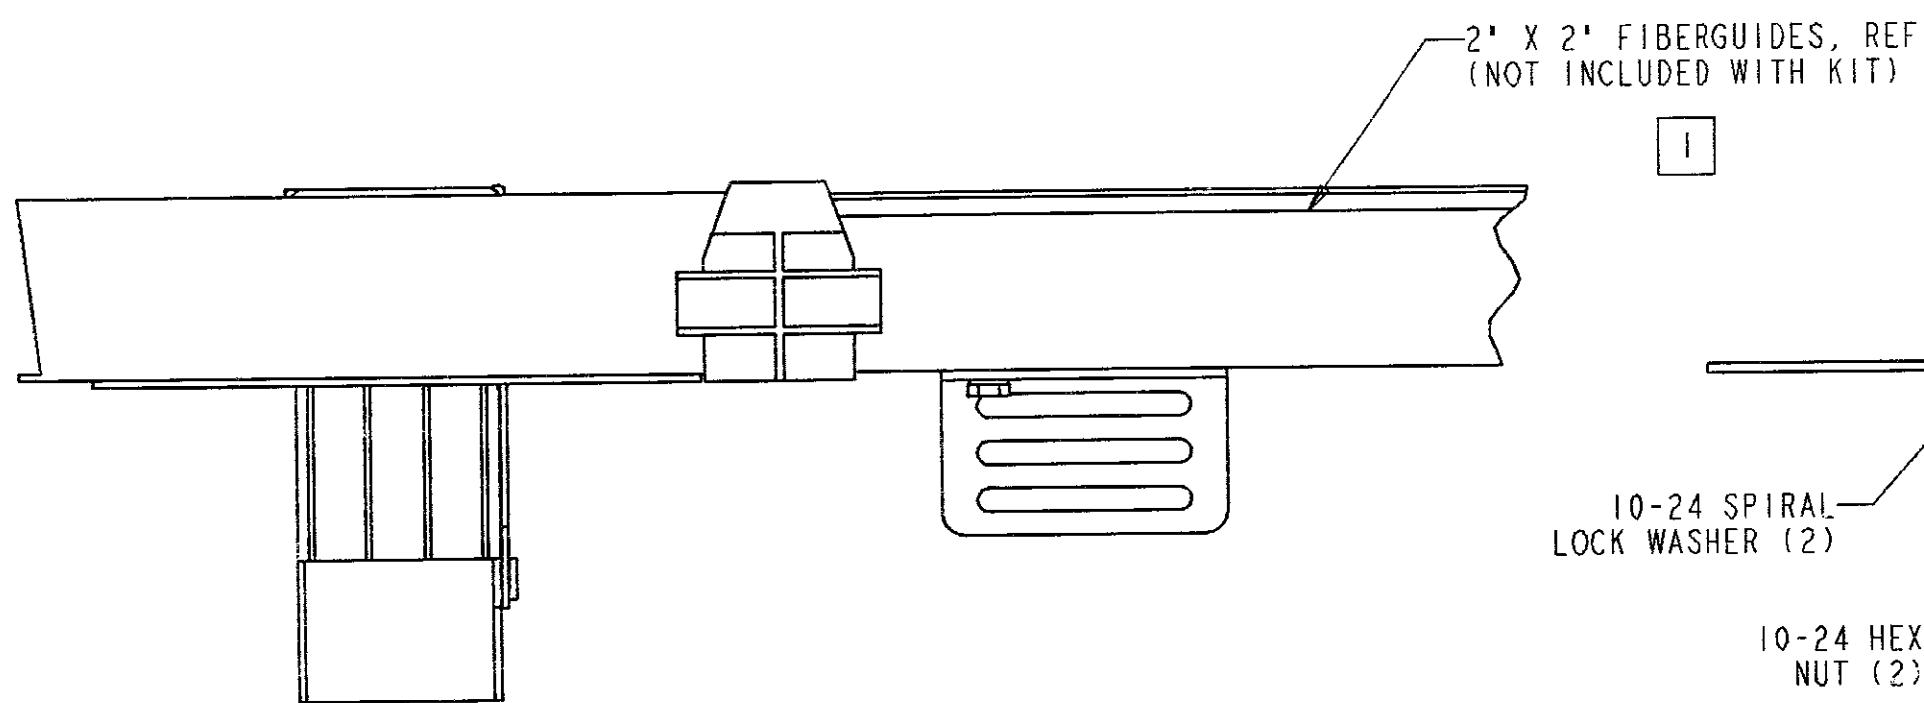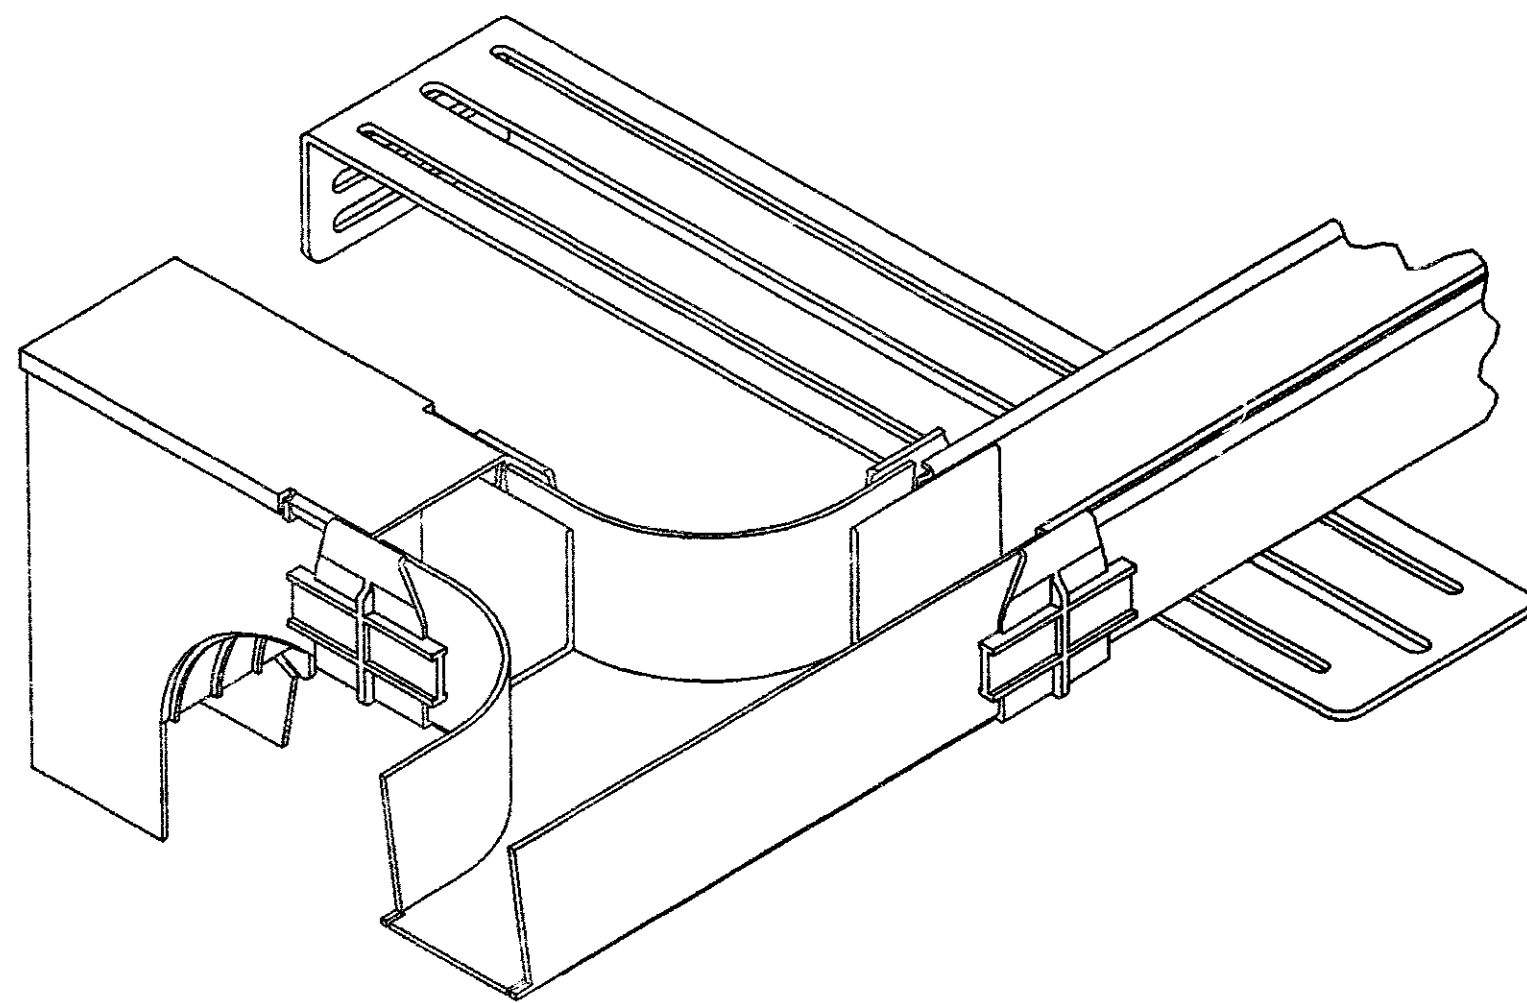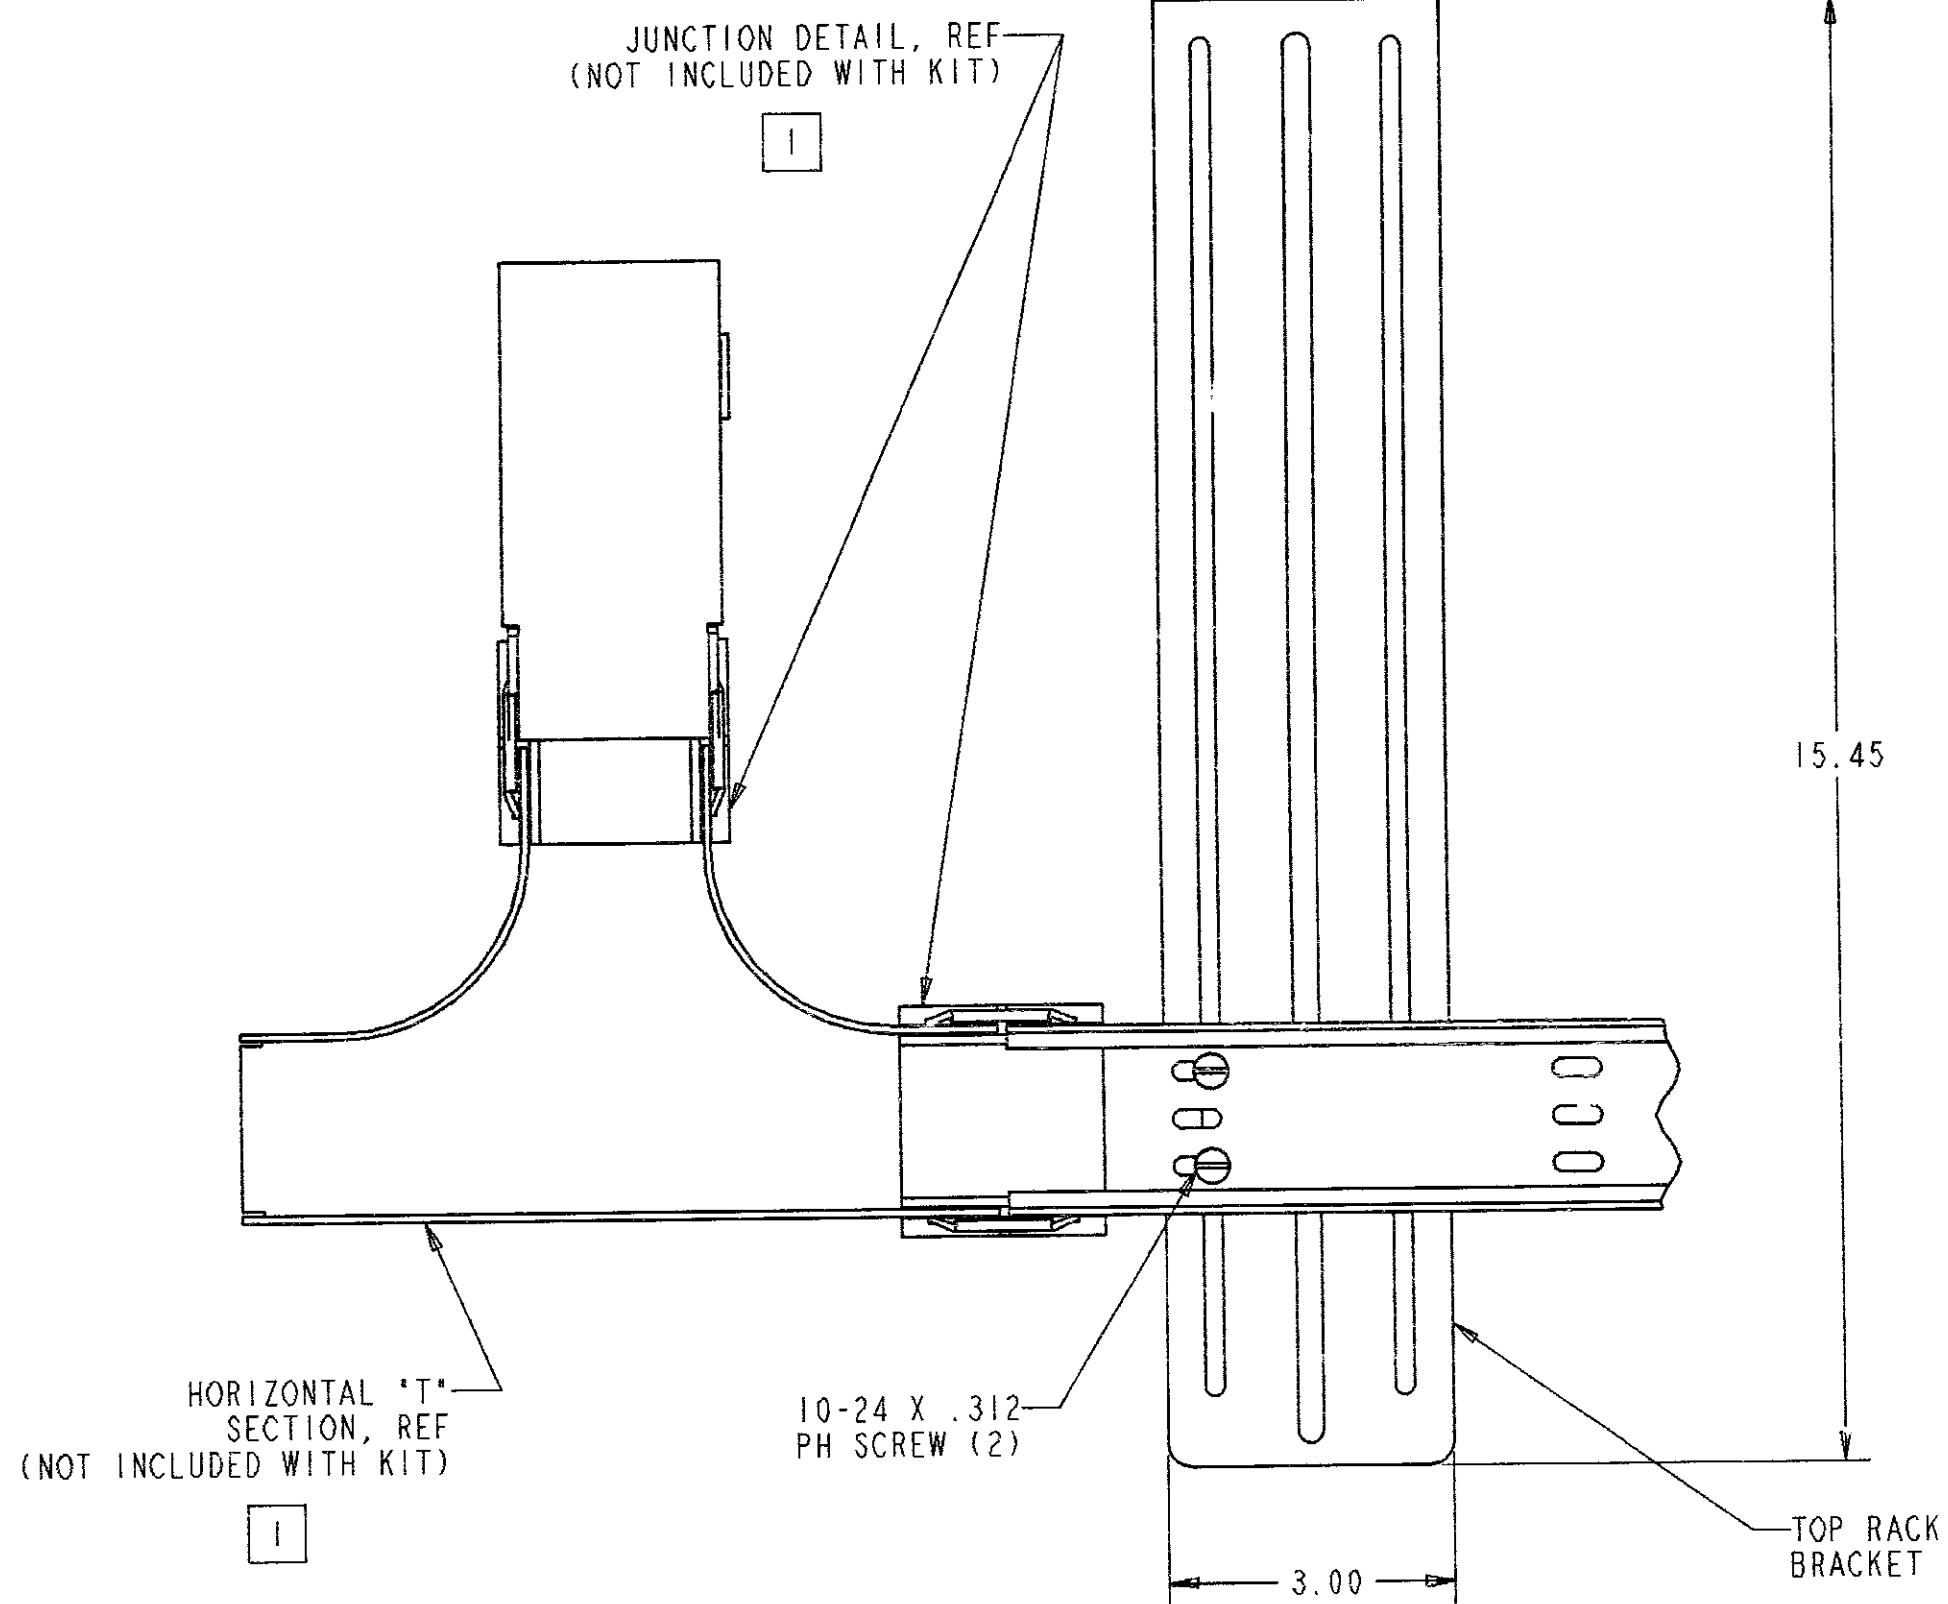

2. 2 #12-24 SCREWS AND WASHERS ARE PROVIDED FOR ATTACHING TO THE RACK.

[1] ITEMS NOT INCLUDED WITH KIT.

NOTES:



INFORMATION ON THIS DOCUMENT IS PROPRIETARY TO ADC AND SHALL NOT BE USED, COPIED, REPRODUCED OR DISCLOSED IN WHOLE OR IN PART WITHOUT WRITTEN CONSENT OF ADC.

TOLERANCE UNLESS OTHERWISE SPECIFIED .XX: REF .XXX: REF ANGULAR: REF

TITLE FIBERGUIDES, KIT TOP RACK BRKT, EXTENDED INSTALLATION DRAWING				
C SIZE	DRAWING NUMBER 4-29000-3231			A REV
ROY HENNEBERGER T. REDMANN				SHT. 1 OF 1

directory: 66904