

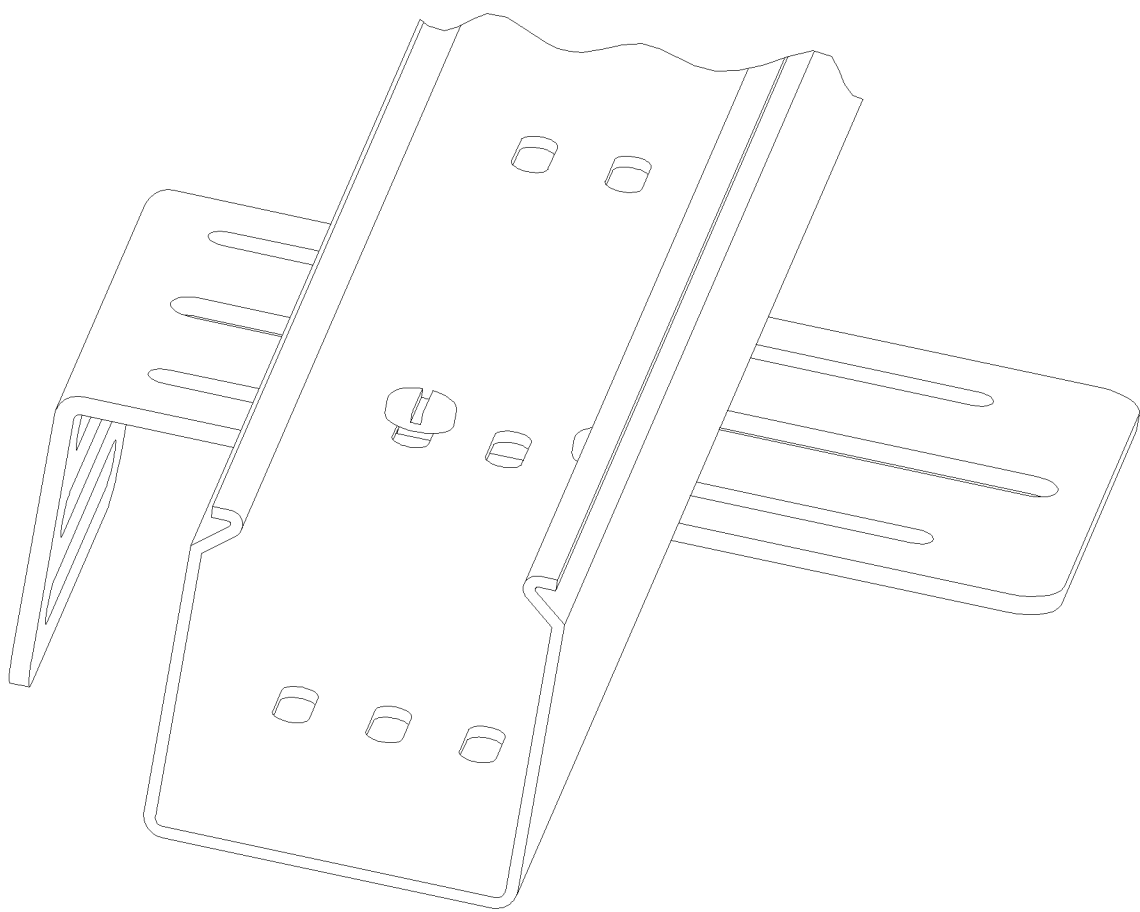
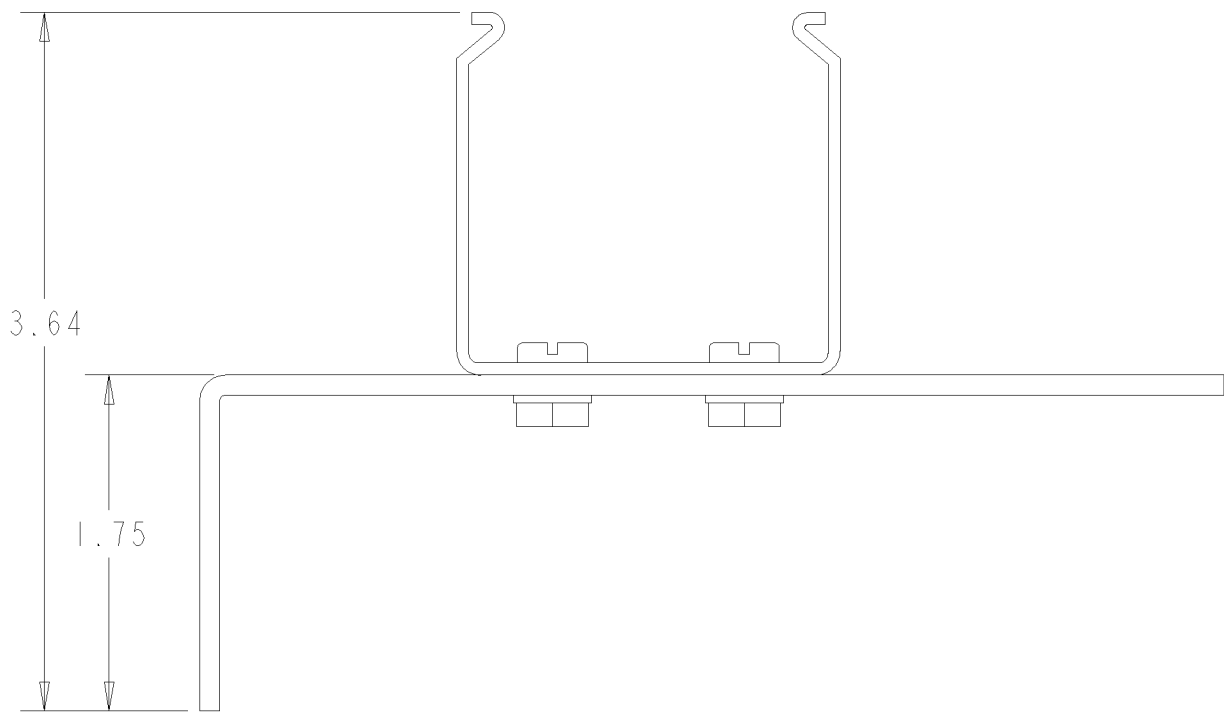



REV	ECO	DWN	DATE
A	66904	DDC	12/20/90
B	20008845	MJM	04/14/98

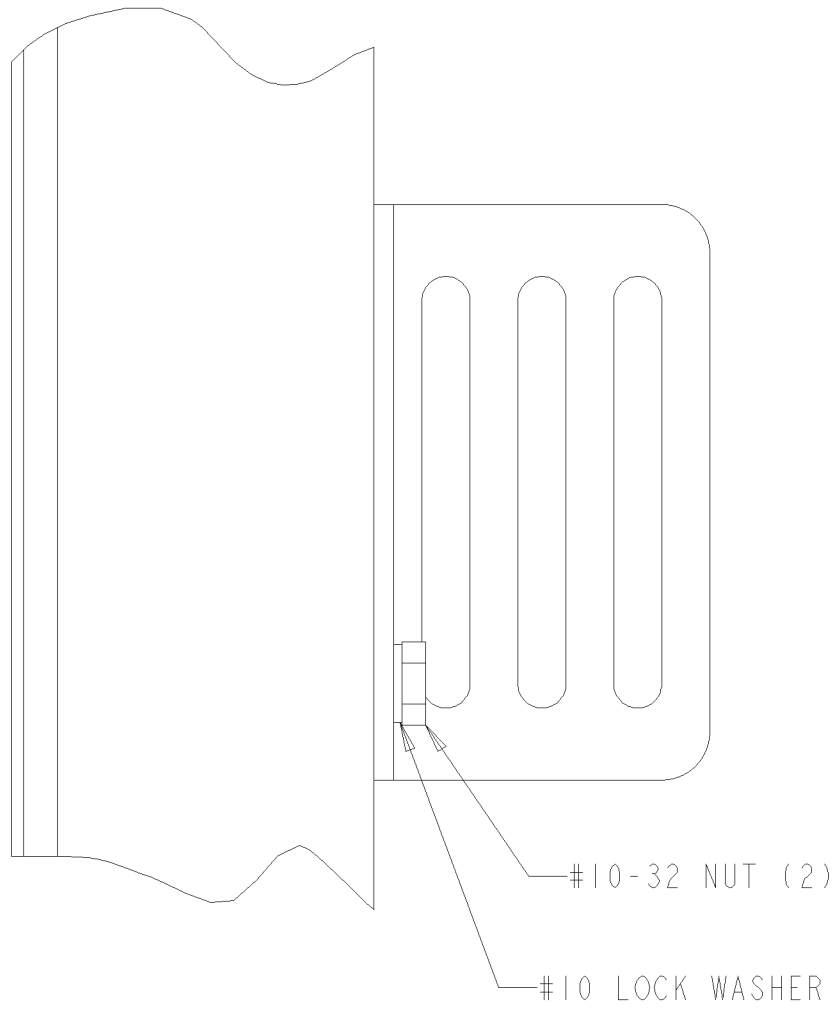

- NOTES:
- 1. FGS-MSHA-C, NOT INCLUDED IN KIT.
 - 2. (2) #12-24 SCREWS AND WASHERS ARE PROVIDED FOR ATTACHING TO THE RACK.

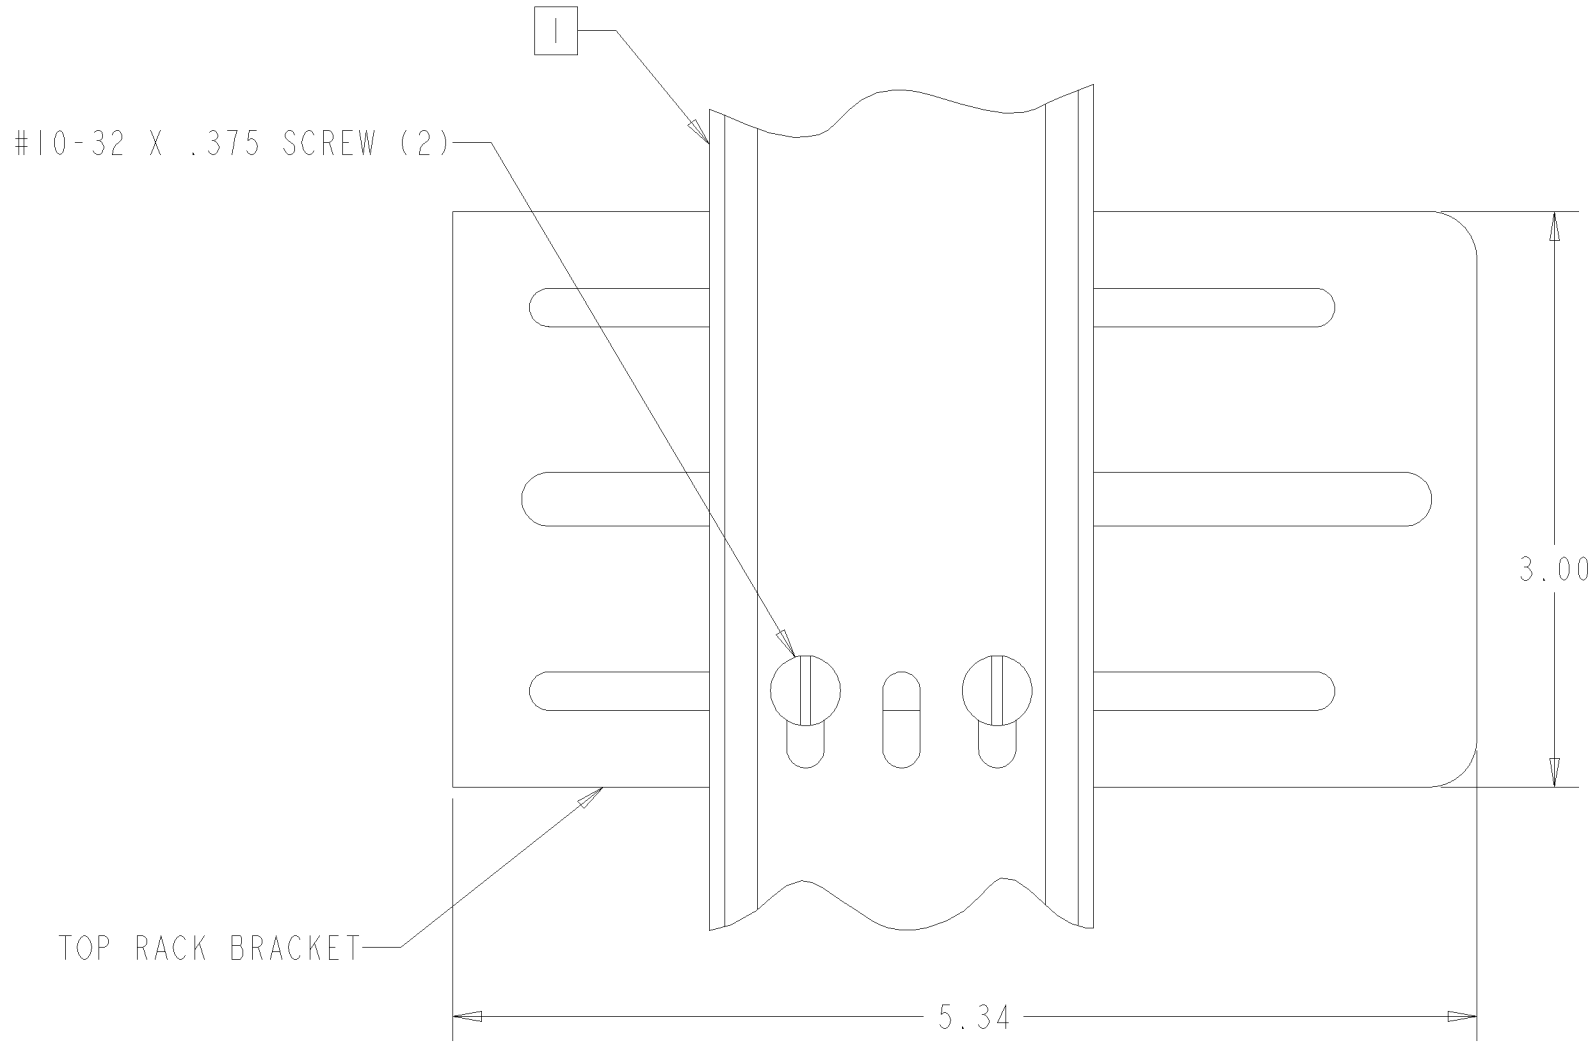

TELECOMMUNICATIONS

INFORMATION ON THIS DOCUMENT IS PROPRIETARY TO ADC AND SHALL NOT BE USED, COPIED, REPRODUCED OR DISCLOSED IN WHOLE OR IN PART WITHOUT WRITTEN CONSENT OF ADC.

TOLERANCE UNLESS OTHERWISE SPECIFIED	.XX: REF .XXX: REF ANGULAR: REF
ENGR: R. HENNEBERGER	DWN: D. CARPENTER

DO NOT SCALE DRAWING

TITLE	FIBERGUIDES TOP RACK BRACKET, SHORT INSTALLATION DRAWING
C SIZE	DRAWING NUMBER 4-29000-3221
B REV	SHT. 1 OF 1